


TYPICAL WALL SECTION


SCALE: 1/2" = 1'-0"

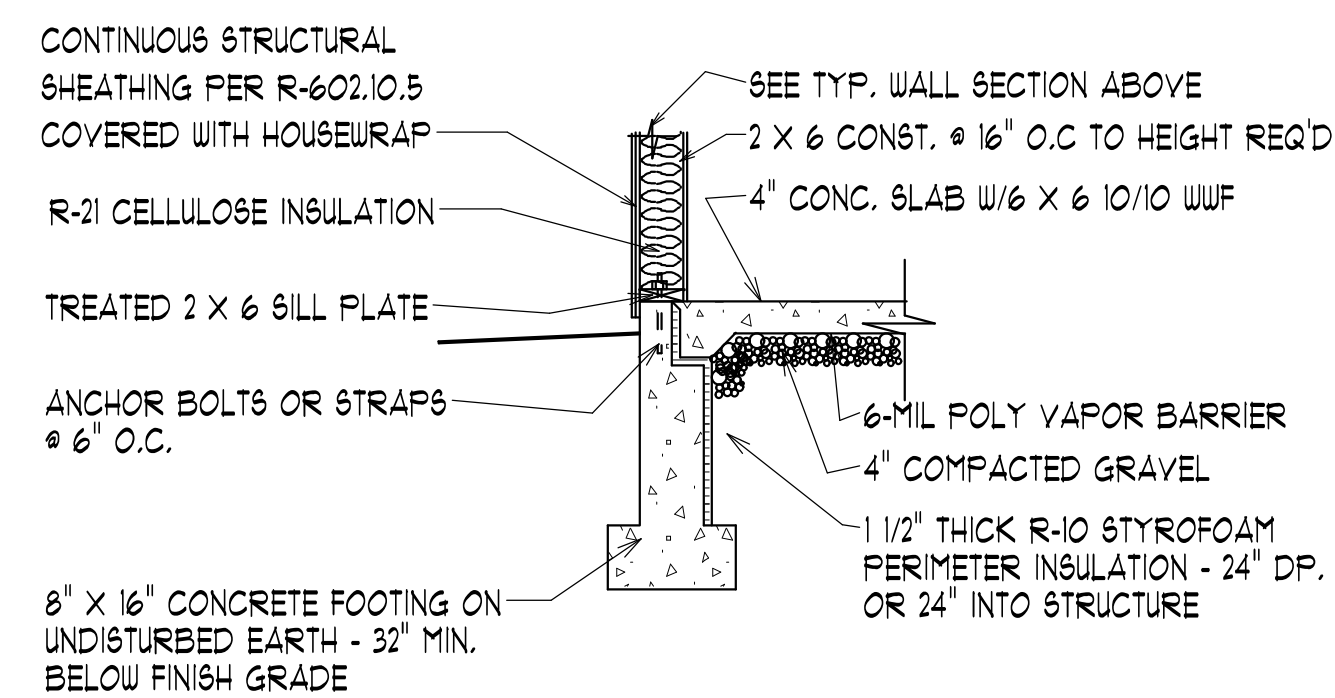

DETAIL "A"

SCALE: 1/2" = 1'-0"

- NOTES:
1. SMOKE DETECTORS MUST BE LOCATED AND INSTALLED IN ACCORDANCE WITH SECTION R-313.
 2. ALL ELECTRICAL EQUIPMENT AND INSTALLATION SHALL COMPLY WITH THE NEC WHICH IS IN EFFECT AT THE TIME OF INSTALLATION.
 3. STAIR CONSTRUCTION MUST COMPLY WITH SECTION R-311.
 4. ALL HANDRAILS AND GUARDRAILS MUST COMPLY WITH SECTION R-312.
 5. FOUNDATION WALL REINFORCEMENT MUST COMPLY WITH SECTION R-404.
 6. FOUNDATION WATERPROOFING MUST COMPLY WITH SECTION R-406.

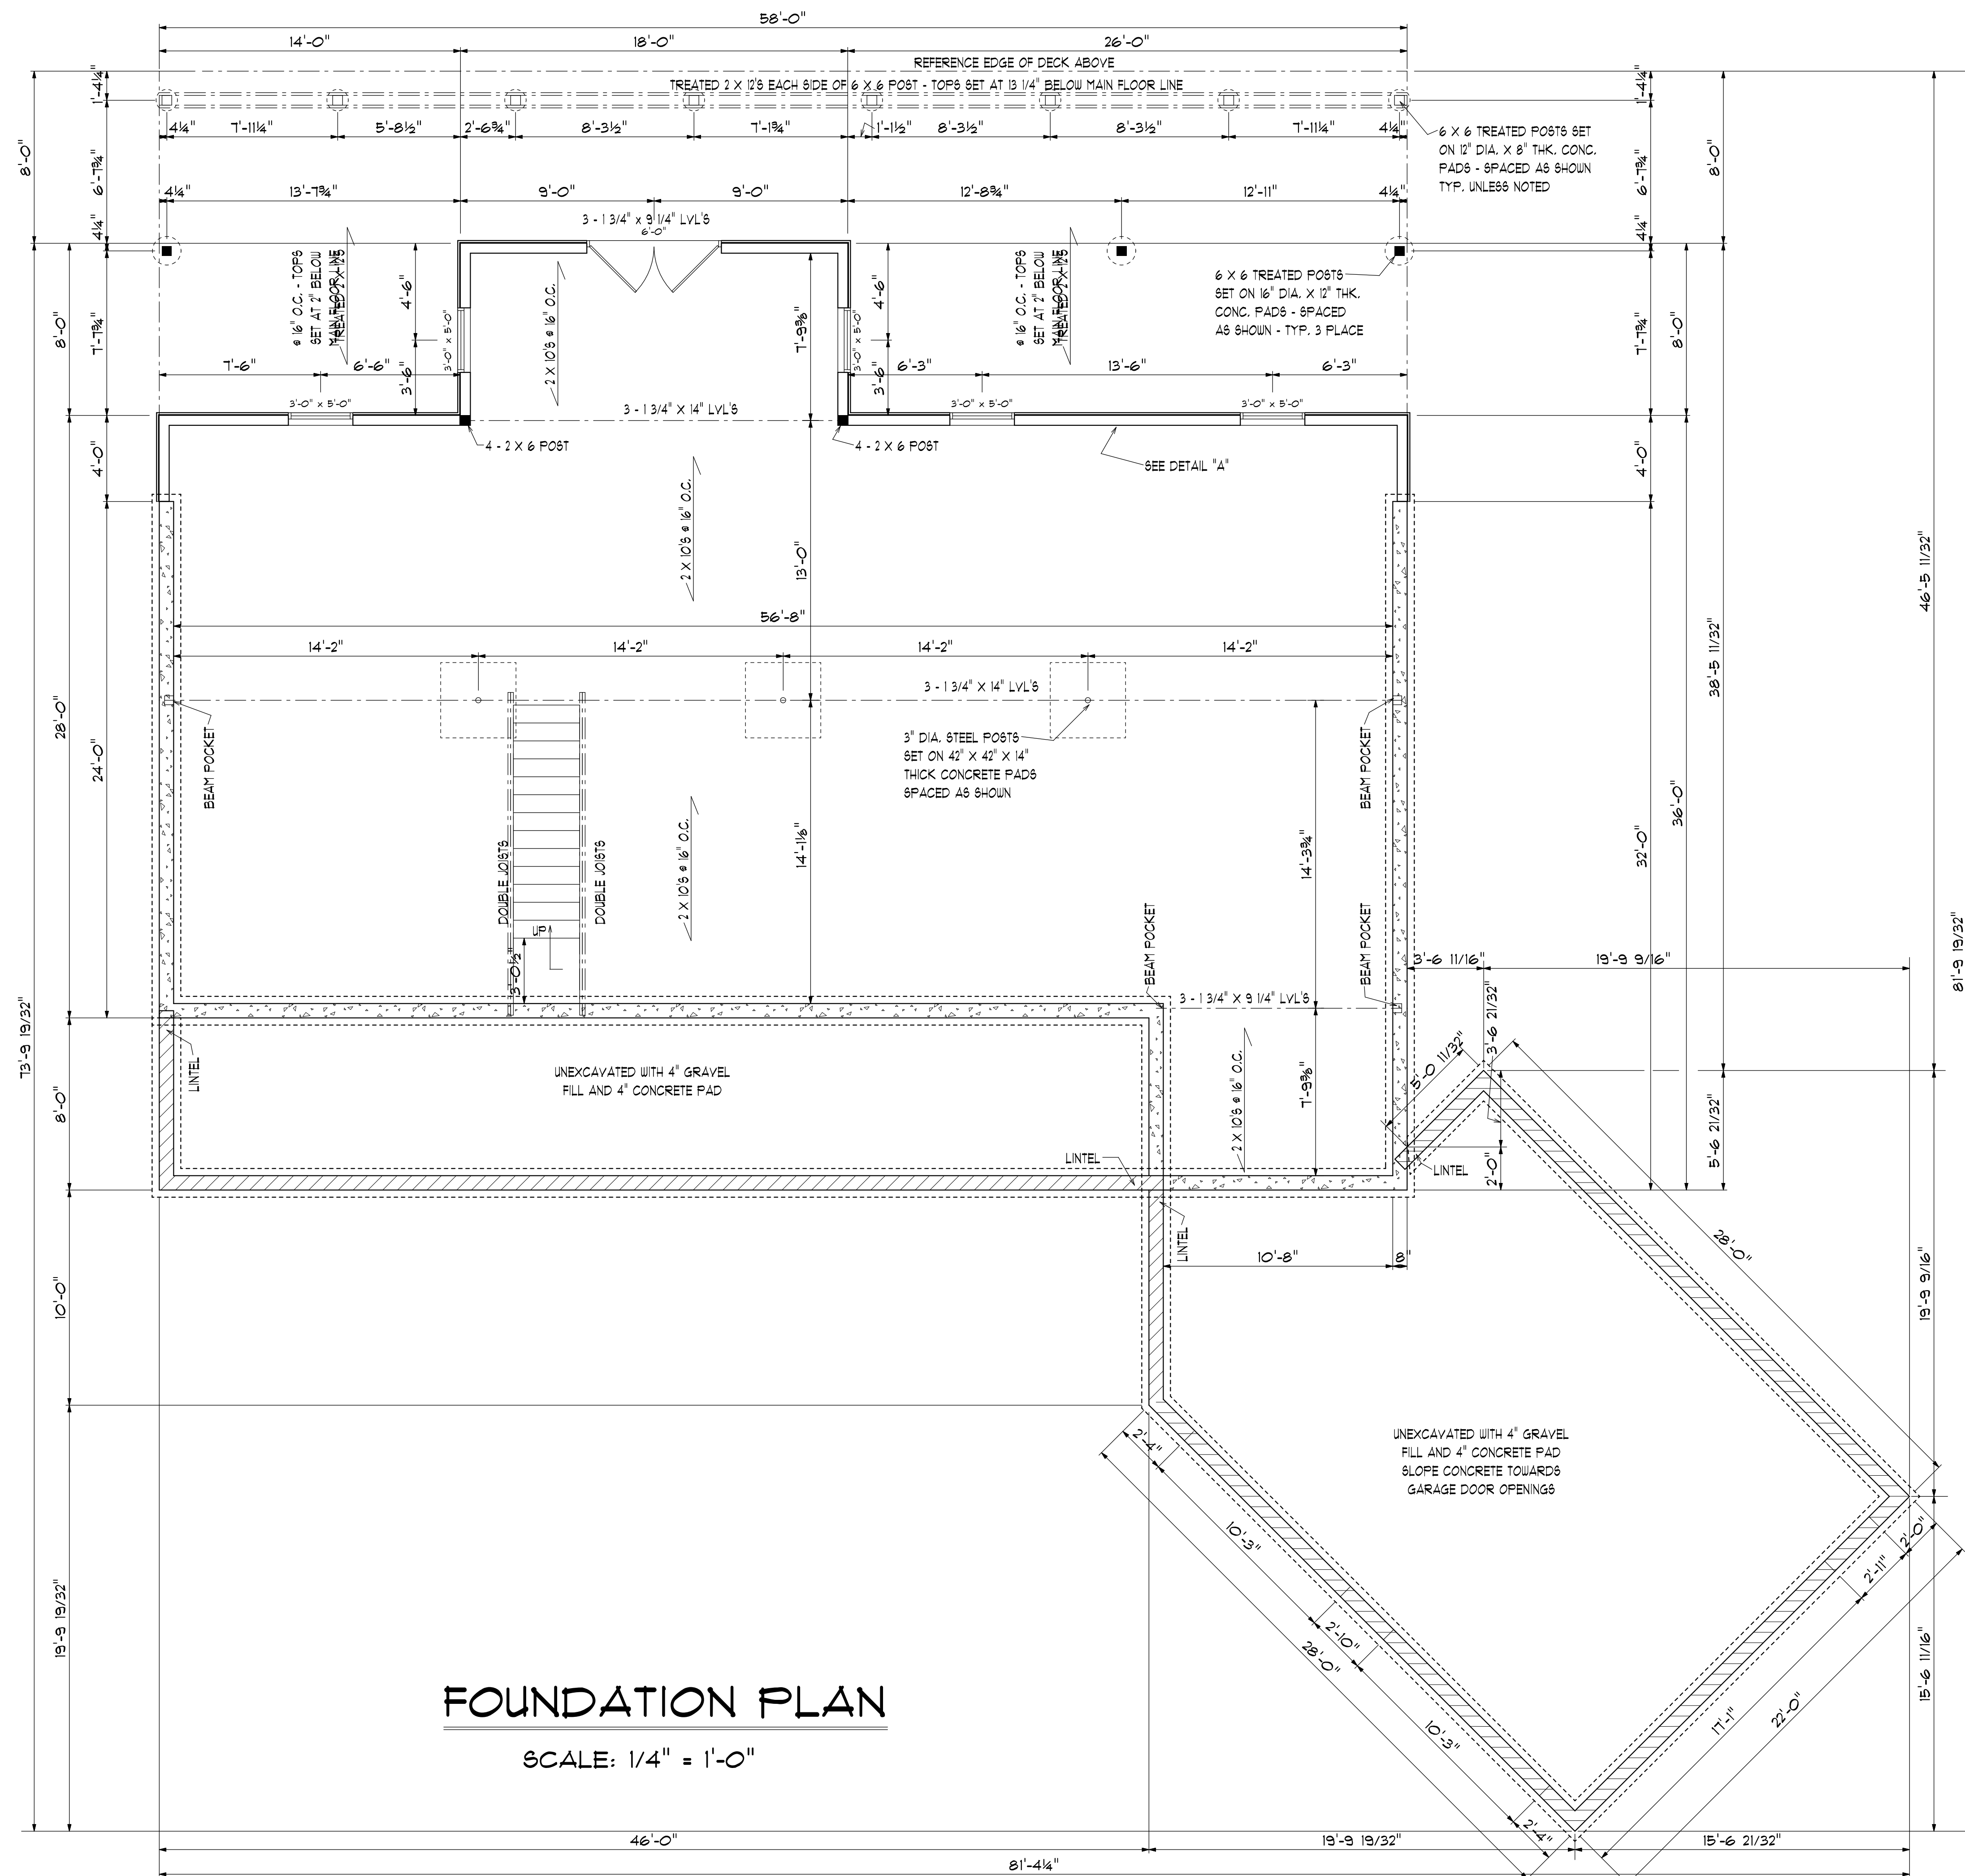

FOUNDATION PLAN

SCALE: 1/4" = 1'-0"